

S I T E P H O T O S

TABLE OF CONTENTS

S I T E




V I C I N I T Y M A P




A1	SITE PHOTOS VICINITY MAP TABLE OF CONTENTS
A2	ROOF PLAN
A3	SECOND FLOOR REFLECTED CEILING PLAN
A4	CEILING FRAMING PLAN
S1	ROOF FRAMING PLAN
S2	RAFTER DETAIL
S3	CONNECTION DETAILS
E1	ELECTRICAL LIGHTING LAYOUT

BENGUET
RE
OCT. 24, 2022
PROCURE



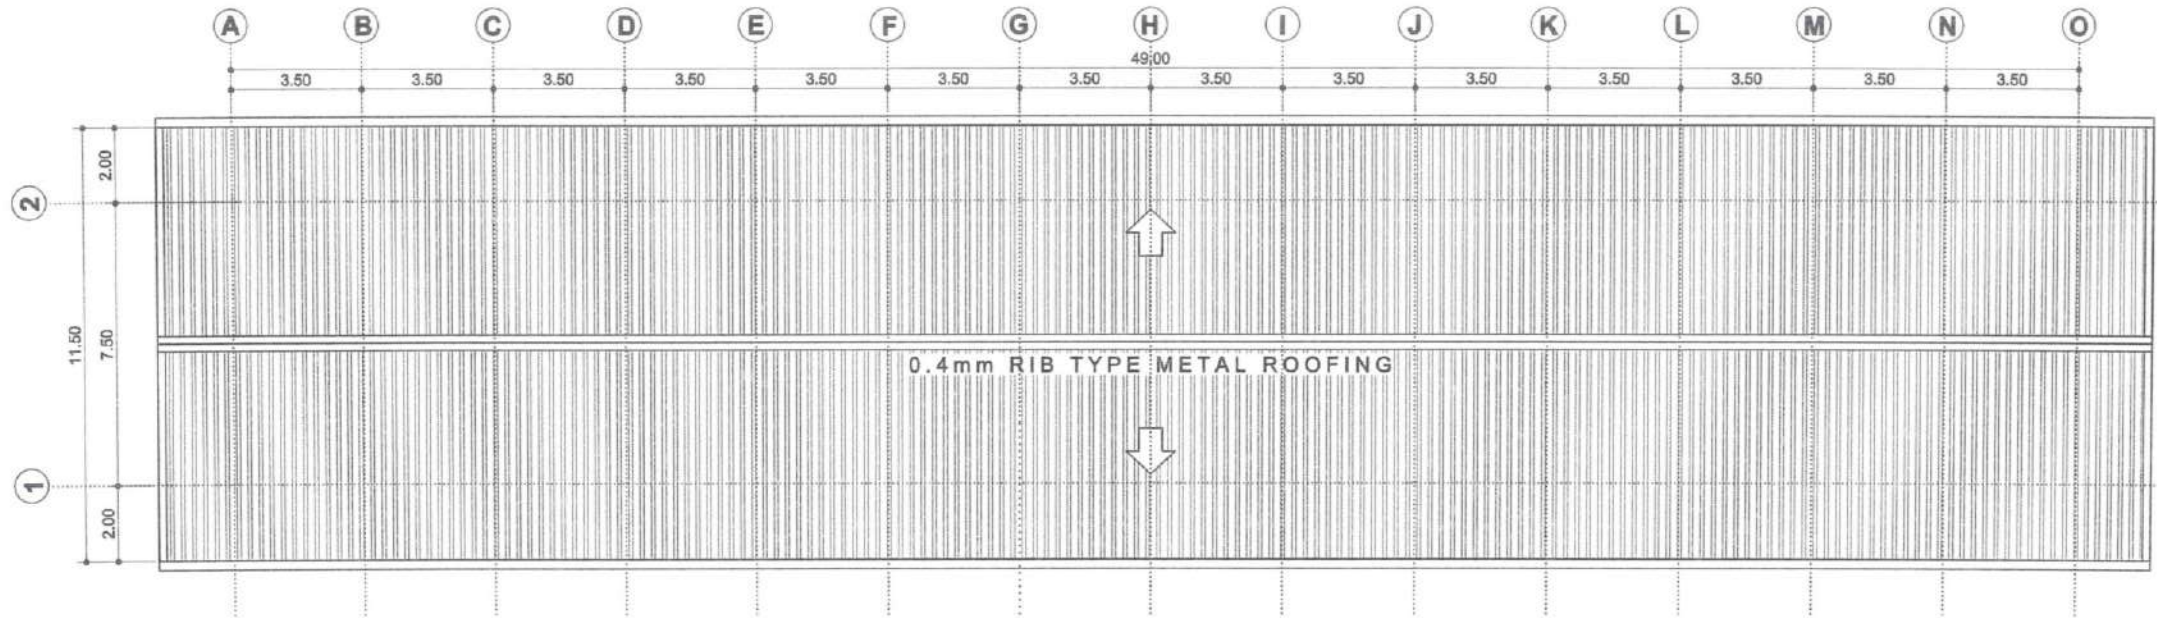


 HAZELINE M. TIBANGAY UNIVERSITY ARCHITECT		PRC LIC. No. 028540 PTR. No.		VALIDITY: ISSUED:		PRC LIC. No. PTR. No.		VALIDITY: ISSUED:		2020 BY: EAS-AUGUST 2022		REPAIR OF THE ELS- MAIN BUILDING BSU, KM5 BSU COMPOUND LA TRINIDAD, BENGUET PROJECT / LOCATION		 BENGUET STATE UNIVERSITY LA TRINIDAD, BENGUET OWNER		 RACHEL KIBAD MAGUEN END USER		 ALLAN CASALDO SACRA VICE PRESIDENT- ADMINISTRATION AND FINANCE		 FELIPE SALANGA COMILA PRESIDENT		SHEET CONTENT AS SHOWN REVISION DATE REVISION NO.:		SHEET NO. A-1 1 0	
---	--	---------------------------------	--	----------------------	--	--------------------------	--	----------------------	--	-----------------------------	--	--	--	--	--	--	--	--	--	---	--	---	--	---------------------------	--

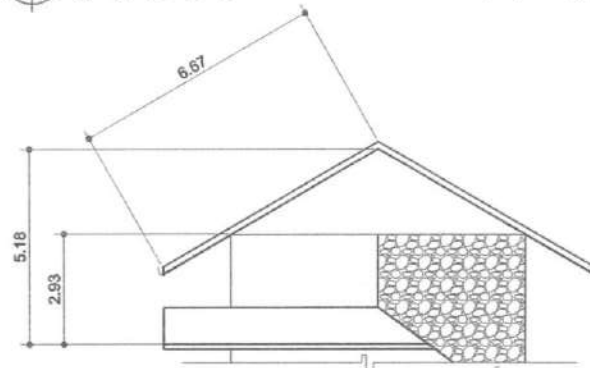


1 R O O F P L A N
 SCALE 1 : 2 0 0 M T S




2 SIDE ELEVATION
 SCALE 1 : 2 0 0 M T S

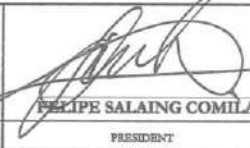
 HAZELINE N. TIBANGAY UNIVERSITY ARCHITECT		VALIDITY: ISSUED:		PRC LIC. No. 028540 PTR No.		VALIDITY: ISSUED:		PRC LIC. No. PTR No.		REPAIR OF THE ELS- MAIN BUILDING BSU, KM5 BSU COMPOUND LA TRINIDAD, BENGUET		 BENUE STATE UNIVERSITY LA TRINIDAD, BENGUET		OWNER		 RACHEL KIBAD MAGUEN END USER		 ALLAN CABALDO SACPA VICE PRESIDENT- ADMINISTRATION AND FINANCE		 FELIPE SALAING COMILA PRESIDENT		SHEET CONTENT AS SHOWN REVISION DATE: REVISION NO.:		SHEET NO. A-2 2 / 8	
--	--	----------------------	--	--------------------------------	--	----------------------	--	-------------------------	--	--	--	---	--	-------	--	---	--	---	--	--	--	--	--	----------------------------------	--

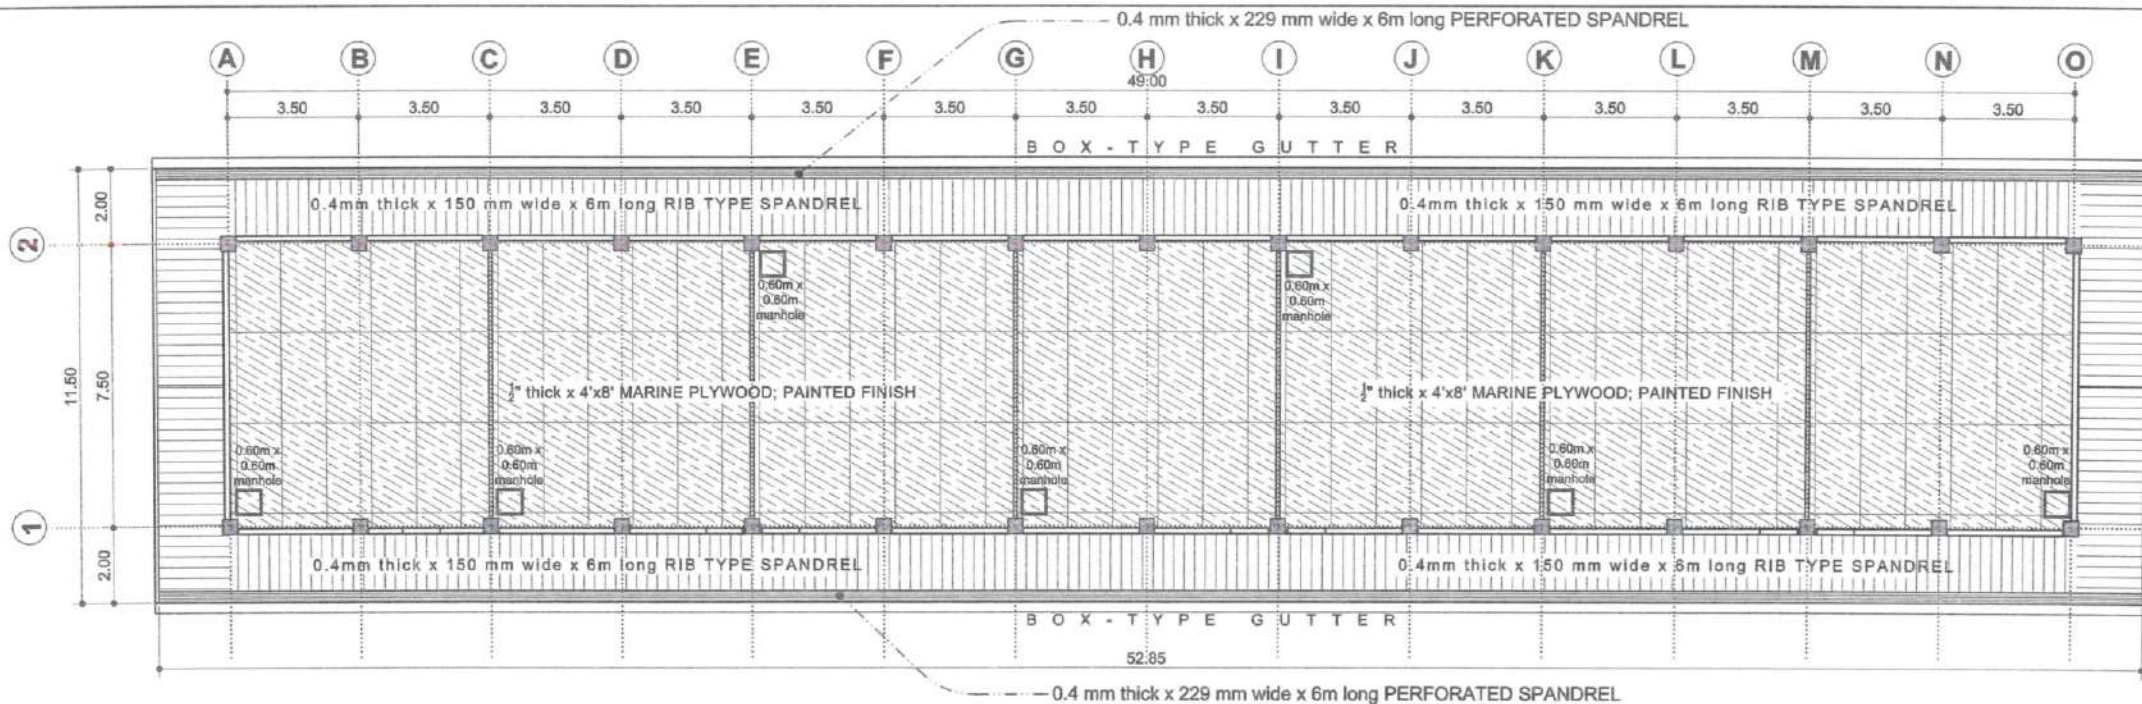


1
A-3 REFLECTED CEILING PLAN
SCALE 1 : 200 MTS

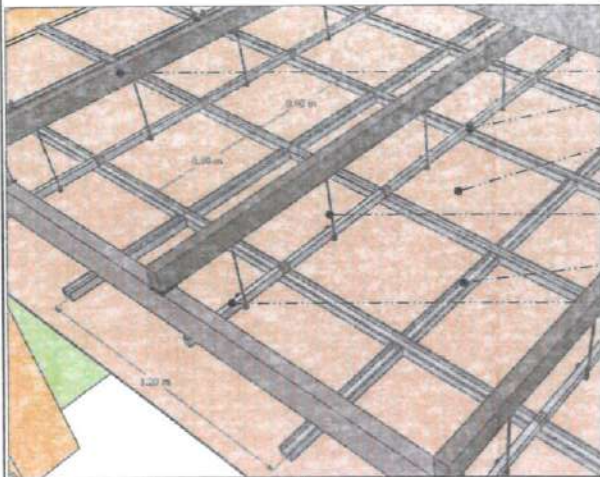



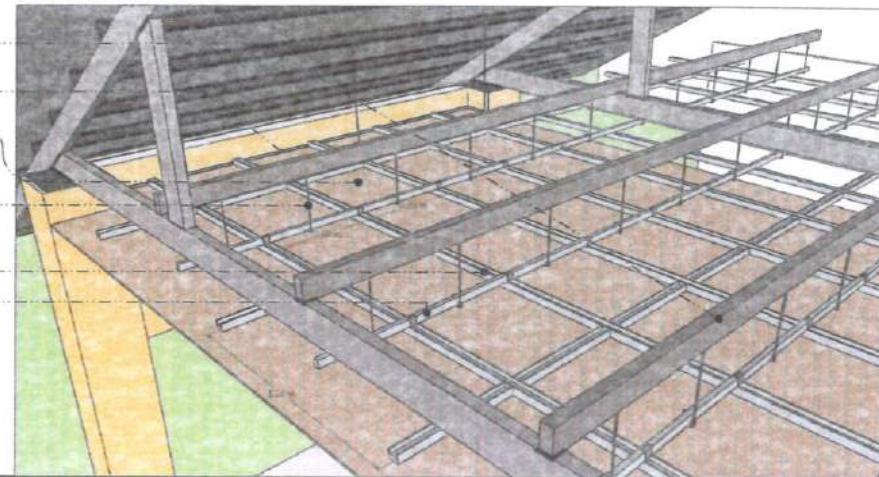


- 50 mm x 50 mm x 6 m, 1.5 mm thick TUBULAR STEEL
- 25 mm x 25 mm x 3 m, 0.5 mm thick WALL ANGLE
- DOUBLE FURRING CLIP
- 1/2" thick x 4' x 8' MARINE PLYWOOD
- 3/8" x 3m THREADED SUSPENSION ROD with SUSPENSION CLIP
- 19 mm x 50 mm x 5 m, 0.5 mm thick DOUBLE FURRING
- 12mm x 38mm x 5m, 0.8mm thick CARRYING CHANNEL

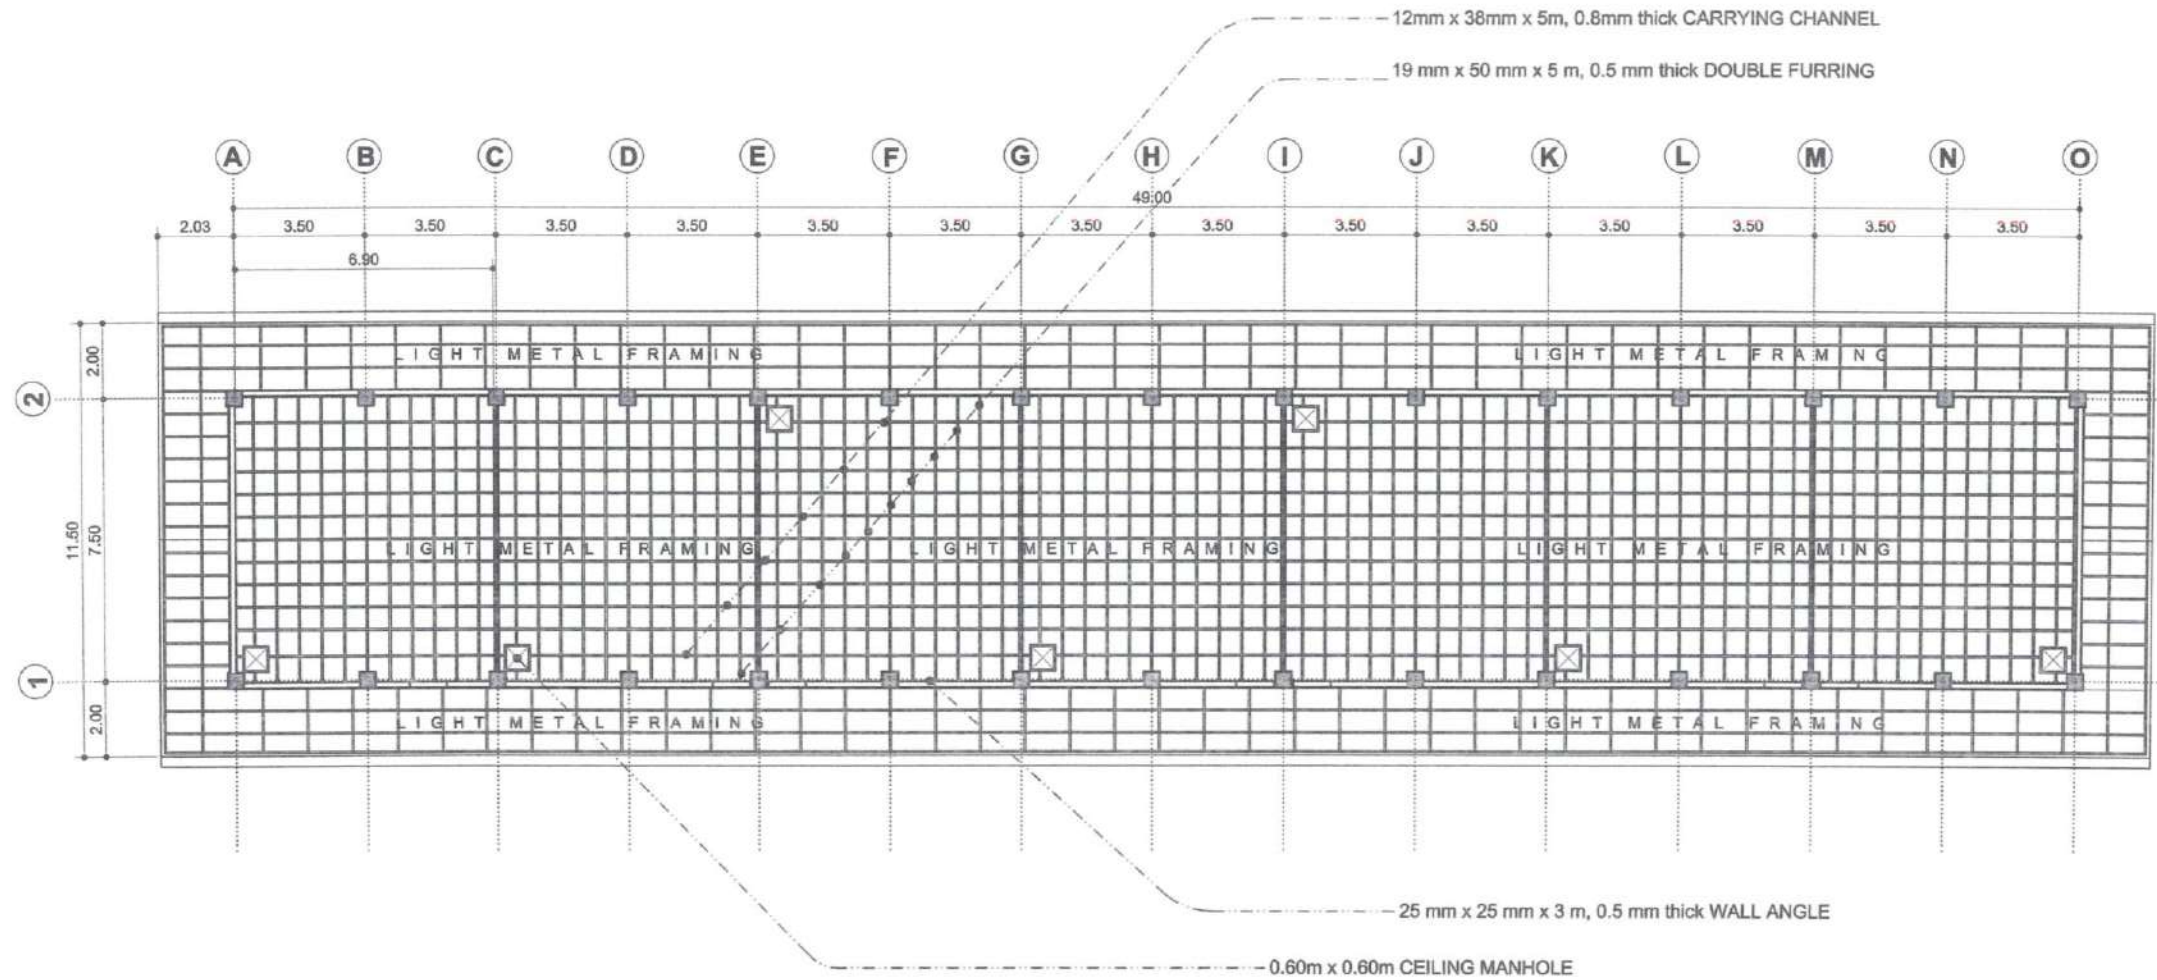


 HAZELINE N. TIBANGAY UNIVERSITY ARCHITECT		REPAIR OF THE BLS- MAIN BUILDING BSUJCM3 BSU COMPOUND LA TRINIDAD, BENGUET		 BENGUET STATE UNIVERSITY LA TRINIDAD, BENGUET		 RACHEL KIBAD MAGUEN END USER		 ALLAN CASALDO SACPA VICE PRESIDENT- ADMINISTRATION AND FINANCE		 FELIPE SALAING COMILA PRESIDENT		SHEET CONTENT AS SHOWN REVISION DATE:	SHEET NO. A-3
PRC LIC. No. 028540 PTR No.	VALIDITY: ISSUED:	PRC LIC. No. PTR No.	VALIDITY: ISSUED:	PROJECT / LOCATION ENR-AUGUST 2022	OWNER	END USER	VICE PRESIDENT- ADMINISTRATION AND FINANCE	PRESIDENT	REVISION NO.:	REVISION DATE:	REVISION NO.: 3 / 8	SHEET NO. 3 / 8	





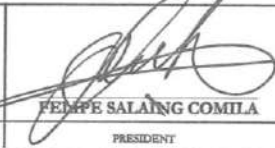



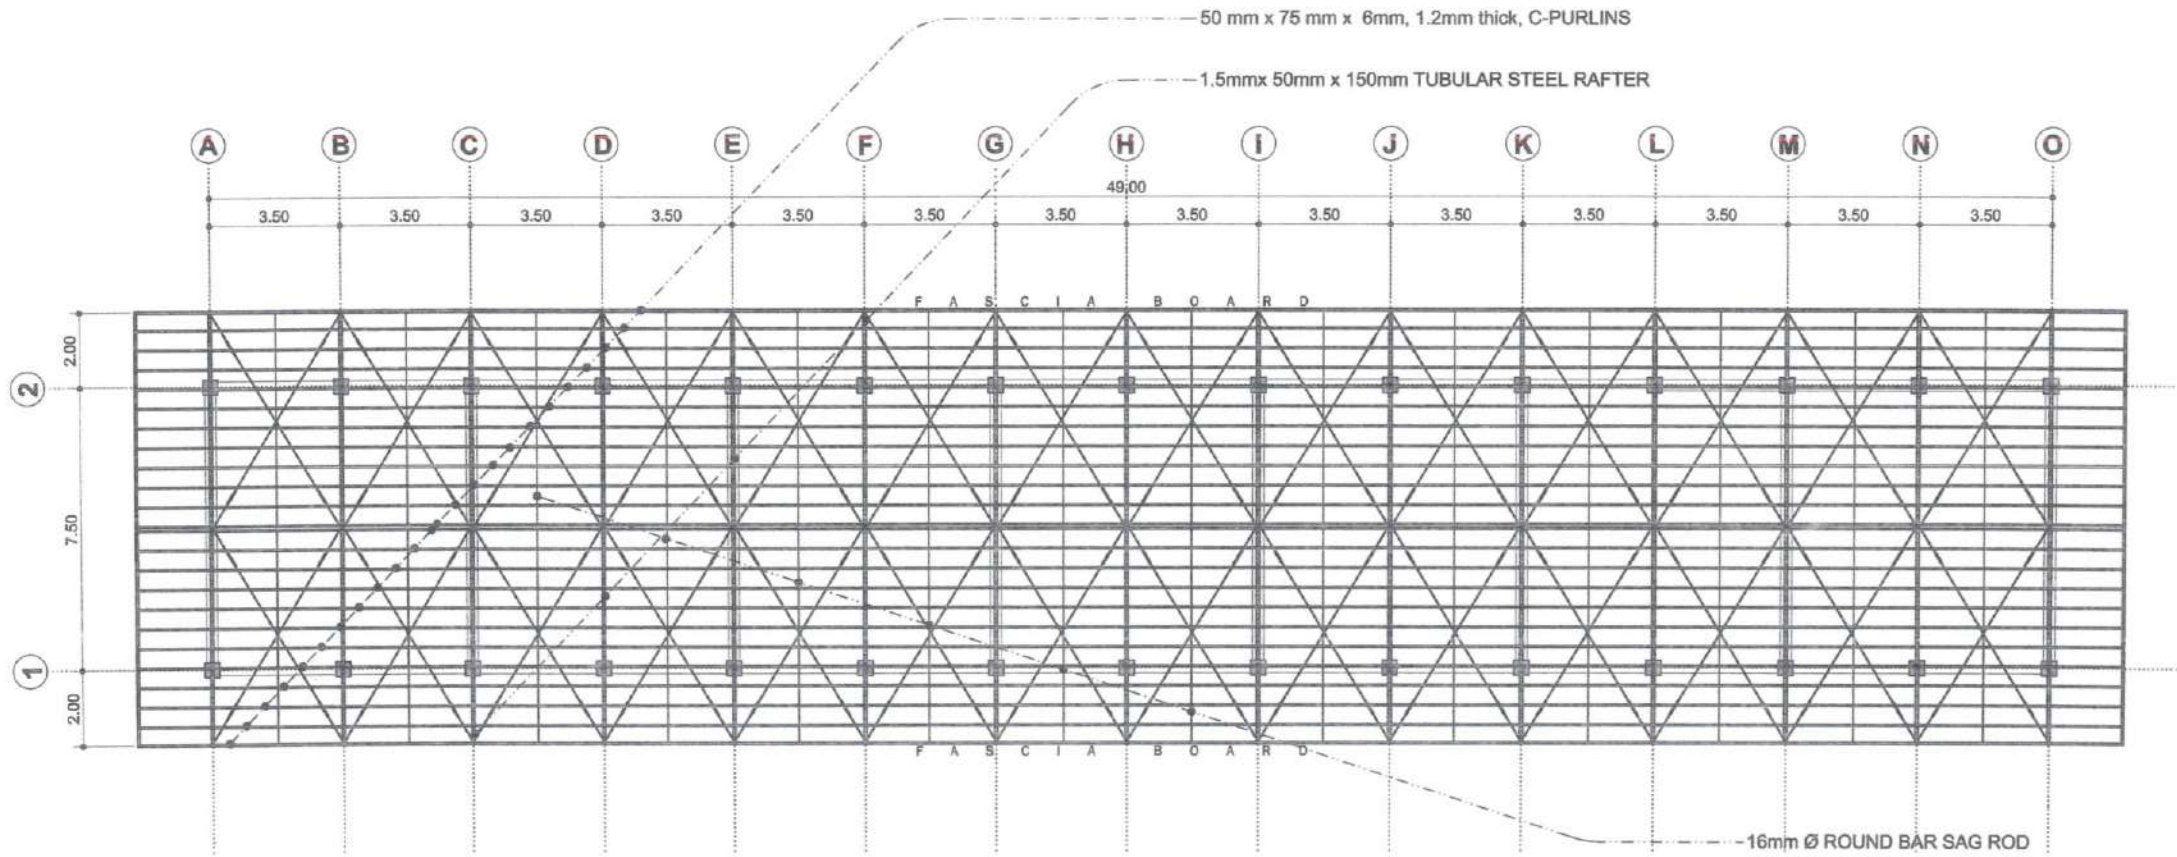
1
A 4
CEILING FRAMING PLAN
 SCALE 1 : 200 MTS

 HAZELINE N. TIBANGAY UNIVERSITY ARCHITECT	PRC LIC. No. 028540 PTR No.	VALIDITY: ISSUED:	PRC LIC. No. PTR No.	VALIDITY: ISSUED:	CAD BY: ENR-AUGUST 2022	REPAIR OF THE ELS- MAIN BUILDING BSU, 36.5 BSU COMPOUND LA TRINIDAD, BENGUET PROJECT / LOCATION	 BENGUET STATE UNIVERSITY LA TRINIDAD, BENGUET OWNER	 RACHEL KIBAD MAGNEN END USER	 ALLAN CASALDO SACPA VICE PRESIDENT- ADMINISTRATION AND FINANCE	 FELMPE SALANG COMILA PRESIDENT	SHEET CONTENT: AS SHOWN REVISION DATE: REVISION NO.:	SHEET NO. <div style="border: 1px solid black; border-radius: 50%; width: 40px; height: 40px; display: flex; align-items: center; justify-content: center; margin: 0 auto;"> A-4 <hr style="width: 80%; margin: 2px 0;"/> 4 8 </div>
--	--------------------------------	----------------------	-------------------------	----------------------	----------------------------	---	--	---	---	---	---	--



1
1 **ROOF FRAMING PLAN**
 SCALE 1 : 200 MTS

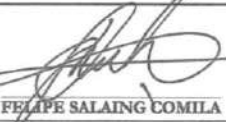 HAZELINE N. TIBANGAY UNIVERSITY ARCHITECT		PRC LIC. No. 028540 PTR No.		VALIDITY: ISSUED:		PRC LIC. No. PTR No.		VALIDITY: ISSUED:		DATE BY: ENG-AUGUST 2022		REPAIR OF THE ELS- MAIN BUILDING BSU JOM5 BSU COMPOUND LA TRINIDAD, BENGUET		 BENGUET STATE UNIVERSITY LA TRINIDAD, BENGUET		OWNER		 RACHEL KIBAD MAGUEN END USER		 ALLAN CASALDO SACRA VICE PRESIDENT-ADMINISTRAYON AND FINANCE		 FELIPE SALANG COMILA PRESIDENT		SHEET CONTENT AS SHOWN REVISION DATE: REVISION NO.:		SHEET NO. S-1 5 / 3	
--	--	--------------------------------	--	----------------------	--	-------------------------	--	----------------------	--	-----------------------------	--	---	--	---	--	-------	--	---	--	---	--	---	--	--	--	----------------------------------	--

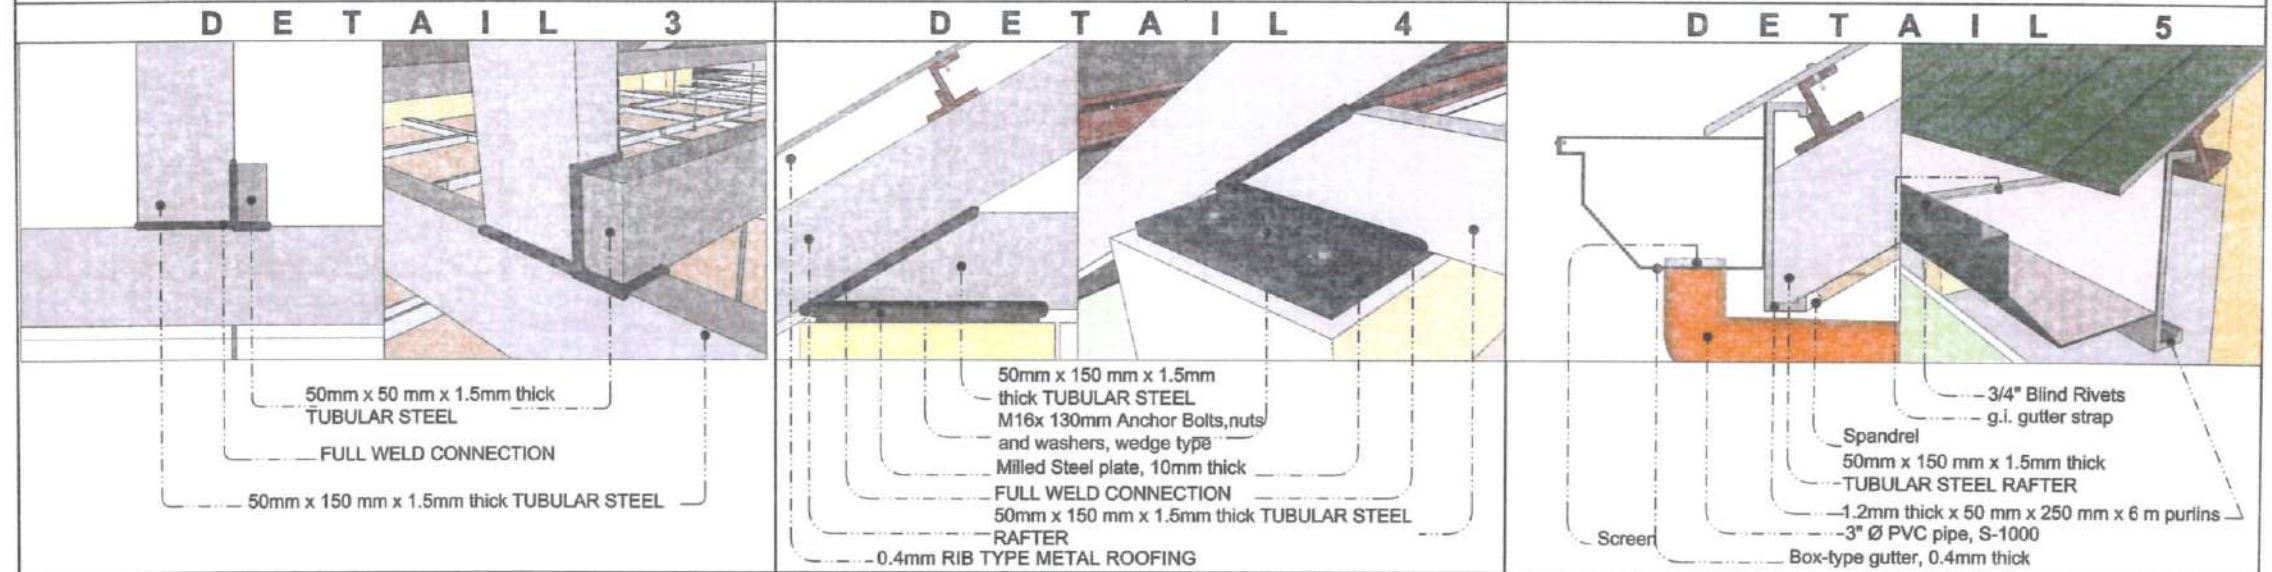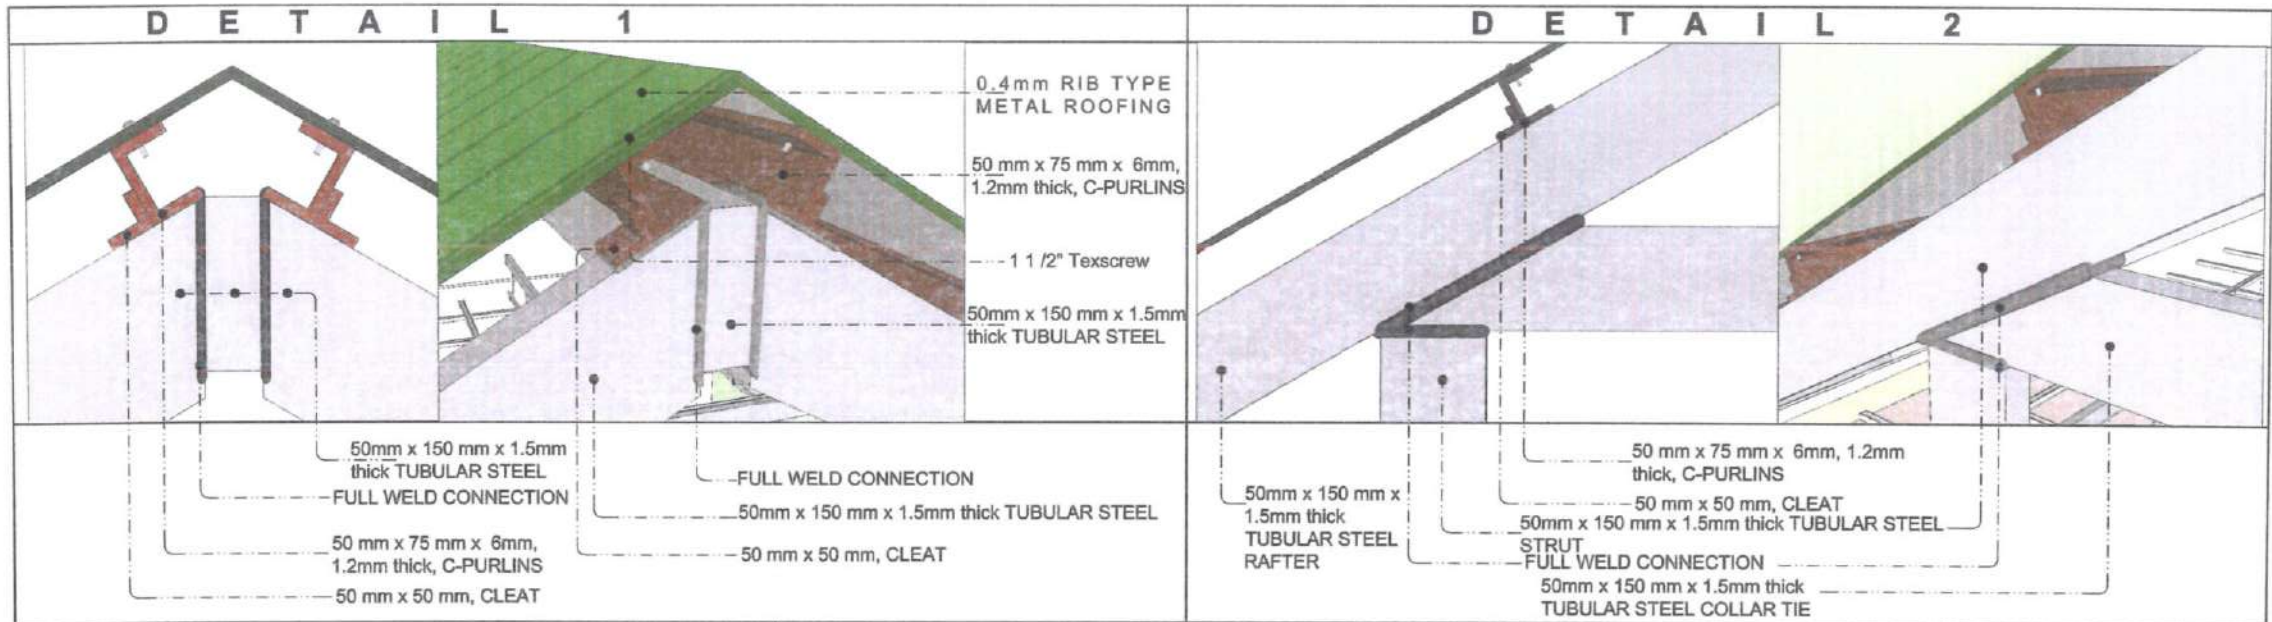


1 CONNECTION DETAILS
S 3 NOT TO SCALE

 HAZELINE N. TIBANGAY UNIVERSITY ARCHITECT	CAD BY: EMAS-AUGUST 2022	REPAIR OF THE ELS-MAIN BUILDING BSU, KM 5 BSU COMPOUND LA TRINIDAD, BENGUET	 BENGUET STATE UNIVERSITY LA TRINIDAD, BENGUET	 RACHEL KIBAD MAGUEN	 ALLAN CASALDO SACPA	 FELIPE SALAING COMILA	SHEET CONTENT AS SHOWN	SHEET NO. S-3
							REVISION DATE	REVISION NO. 7 8
PRC LIC. No. 028540 PTR No.	VALIDITY: ISSUED:	PROJECT / LOCATION	OWNER	END USER	VICE PRESIDENT- ADMINISTRATION AND FINANCE	PRESIDENT	REVISION NO.	

L E G E N D

	2-T8 LED LAMP WITH HOUSING AND DIFFUSER
	S1 SINGLE SWITCH
	S2 2-GANG SWITCH
	CIRCUIT/HOMERUN

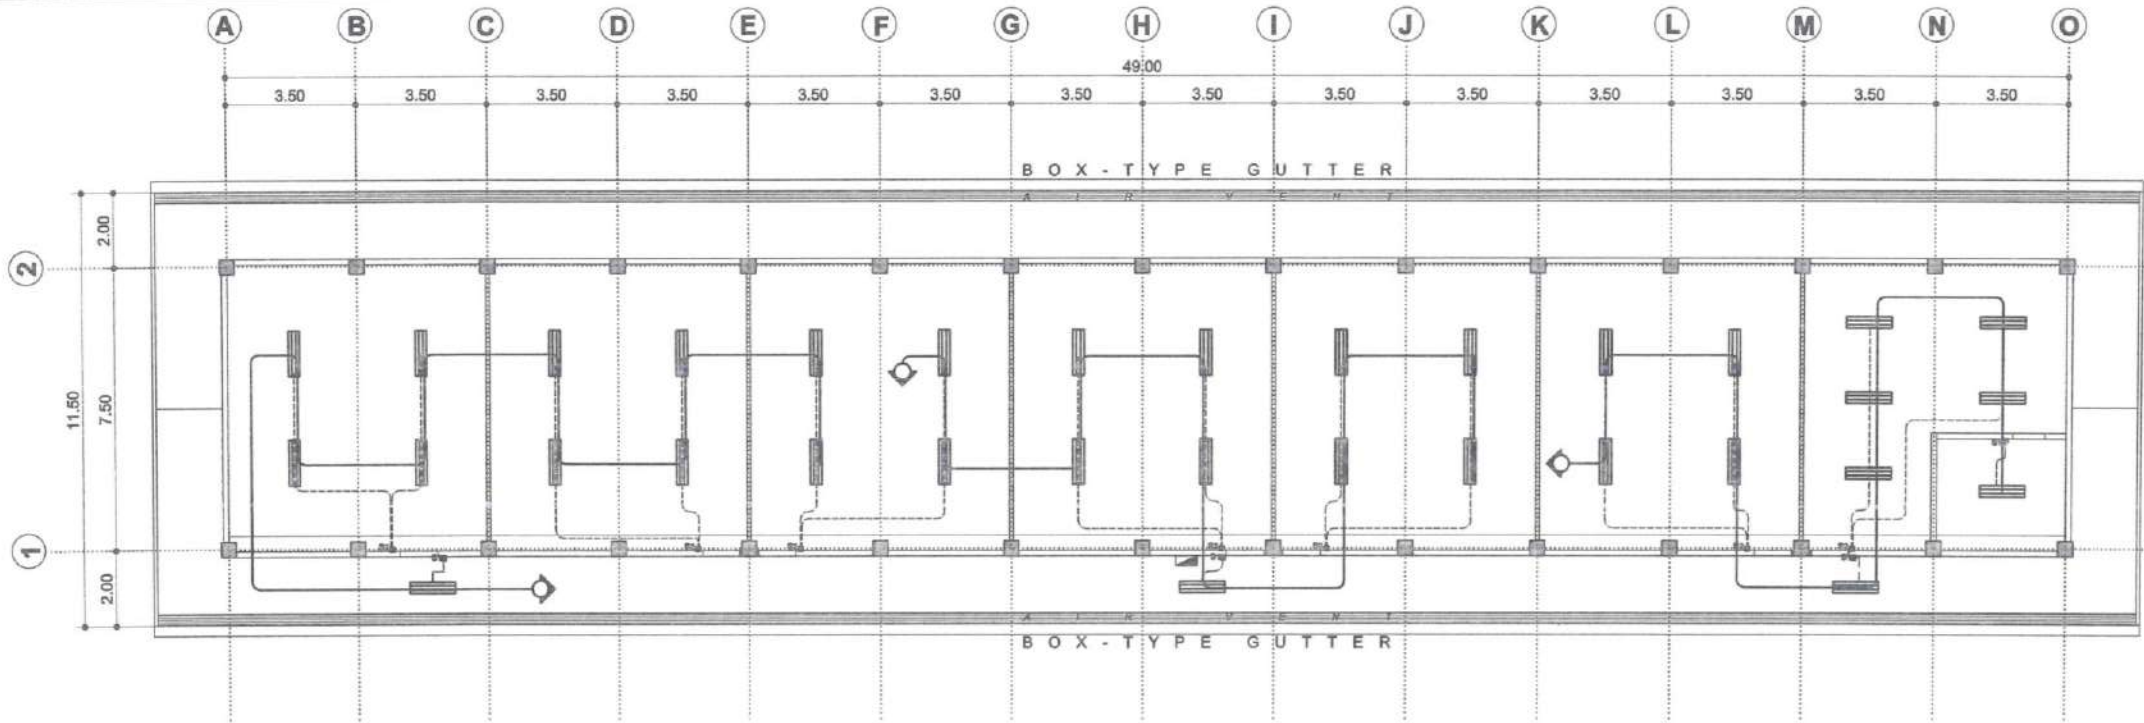

1
E 1 **ELECTRICAL LIGHTING LAYOUT**
SCALE 1 : 200 MTS

 HAZELINA N. TIBANGAY UNIVERSITY ARCHITECT	CAD BY: EAS-AUGUST 2022	REPAIR OF THE HLS- MAIN BUILDING BSU KMS BSU COMPOUND LA TRINIDAD, BENGUET	 BENGUET STATE UNIVERSITY LA TRINIDAD, BENGUET	 RACHEL KIBAD MAGUEN	 ALLAN CASALDO SACPA	 FELIPE SALAING COMILA	SHEET CONTENT	SHEET NO.
							AS SHOWN	E-1
PRC LIC. No. 028540 PTR No.	VALIDITY: ISSUED:	PRC LIC. No. PTR No.	VALIDITY: ISSUED:	PROJECT / LOCATION	OWNER	END USER	VICE PRESIDENT- ADMINISTRATION AND FINANCE	PRESIDENT