

**1 SECOND FLOOR PLAN (Administration Building)**  
 SCALE 1:300MTS

**TABLE OF CONTENTS**

- A1 ADMINISTRATION BUILDING SECOND FLOOR PLAN
- A2 TABLE OF CONTENTS
- A3 AS-BUILT PLAN
- A4 SITE PHOTOS
- A5 RENOVATION PLAN
- A6 PERSPECTIVES
- A7 REFLECTED CEILING PLAN (As-built)
- A8 SITE PHOTOS
- A9 REFLECTED CEILING PLAN (Renovation)
- A10 PERSPECTIVE (Male Wash Area)
- A11 PERSPECTIVE (Female Wash Area)
- A12 SECTION THRU "X"
- A13 SECTION THRU "Y"
- A14 SECTION THRU "Z"
- A15 PERSPECTIVES
- A16 WASH AREA COUNTER DETAIL (Handwashing)
- A17 WASH AREA COUNTER DETAIL (Utensils)
- A18 PERSPECTIVES
- E1 ELECTRICAL LIGHTING LAYOUT
- E2 MOUNTING HEIGHTS
- E3 LEGEND
- P1 SANITARY LINE LAYOUT
- P2 WATERLINE LAYOUT
- P3 WATER CLOSET DETAIL
- P4 URINAL DETAIL
- P5 LAVATORY DETAIL



**PHOTO 1**

	<b>HAZELIN M. BANGAY</b> UNIVERSITY ARCHITECT	PRIC. LIC. No. 028540 VALIDITY: ISSUED	PRIC. LIC. No. 028540 VALIDITY: ISSUED	PROJECT / LOCATION <b>REPAIR OF OLD ADMIN COMFORT ROOM</b> BSU KM 5 BSU COMPOUND LA TRINIDAD, BENGUET		<b>BENGUET STATE UNIVERSITY</b> LA TRINIDAD, BENGUET		<b>JOHN JAMES F. MALAMUG</b> VP ADMINISTRATION AND FINANCE		<b>DIR. DANILLO B. BOSE</b> SIG-PRESIDENT	END-USER Procurement Office
--	--	---	---	---	--	---	--	---	--	--	--------------------------------

SHEET CONTENT	SHEET NO.
AS SHOWN	A-1
REVISION DATE:	

By

AUG 19, 2020

**SITE PHOTOS (Male CR)**



Existing flush doors (cubicle doors) to be removed and replaced

Existing urinals and tiles, to be removed and replaced

Existing concrete counter, to be demolished  
Existing lavatories, to be removed and replaced


**SITE PHOTOS (Female CR)**



Existing flush doors (cubicle doors) to be removed and replaced

Existing concrete counter, to be demolished  
Existing lavatories, to be removed and replaced

Existing flush door to be removed and replaced with  
Pre-fabricated hollow core/flush door with peephole

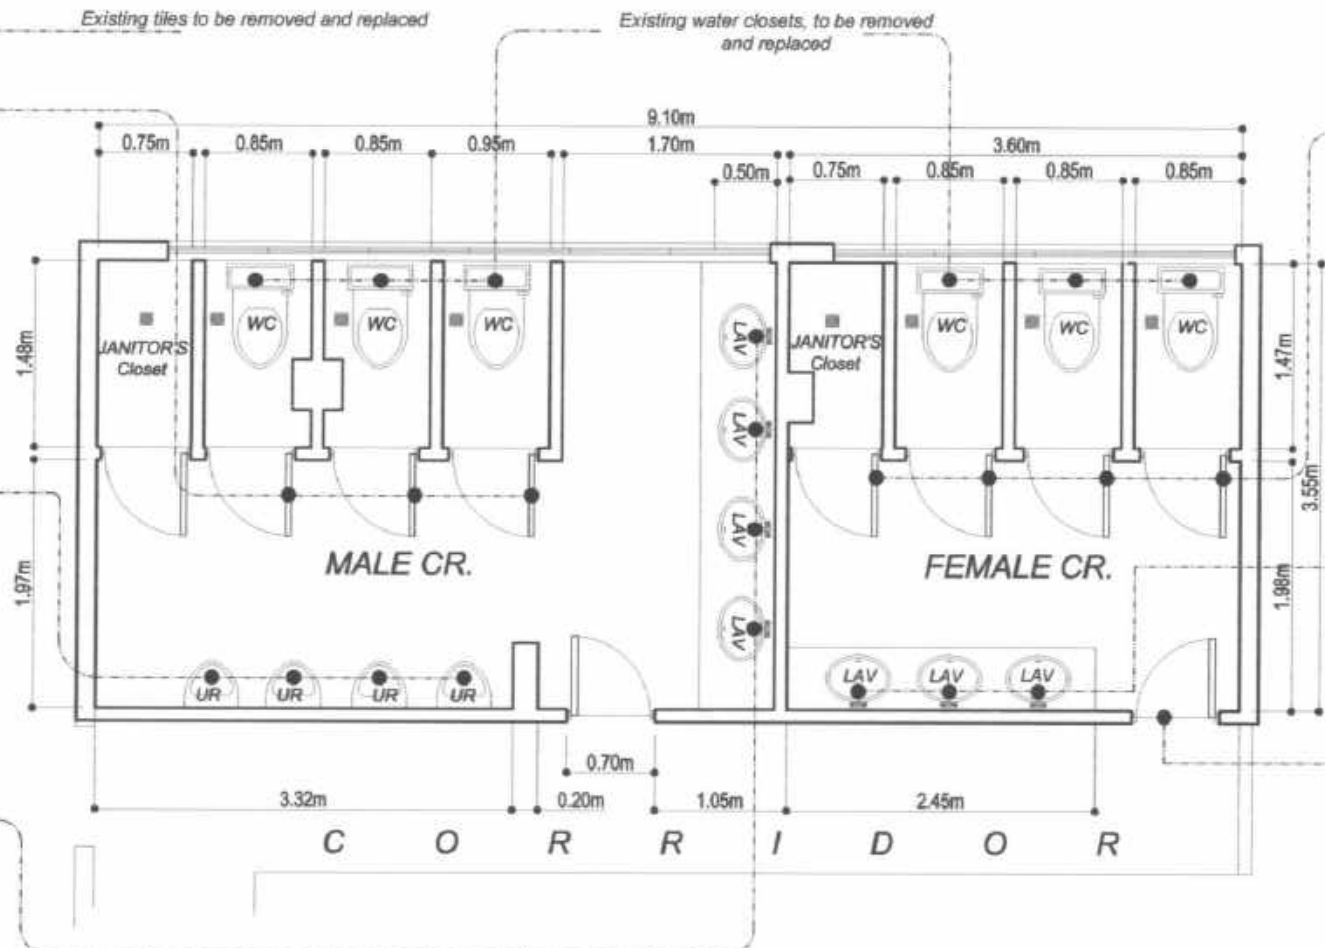

Existing tiles to be removed and replaced


Existing water closets, to be removed and replaced

Existing wall tiles, to be removed and replaced with  
40mm x 40mm porcelain glazed wall tiles

Existing floor tiles, to be removed and replaced with  
40mm x 40mm porcelain textured non-slip floor tiles

**1 AS-BUILT PLAN**  
SCALE 1:60MTS


<p><b>HAZELINE N. BANGAY</b> UNIVERSITY ARCHITECT</p>	<p>PRC LIC. No. 028848 PTR No.</p>	<p>VALIDITY: ISSUED:</p>	<p>PRC LIC. No. PTR No.</p>	<p>VALIDITY: ISSUED:</p>	<p>END BY: MAICA - OCT. 2018 ENG. - JULY 2020</p>	<p><b>REPAIR OF OLD ADMIN COMFORT ROOM</b> BSU JAMES BSU COMPOUND LA TRINIDAD, BENGUET</p>	<p><b>BENGUET STATE UNIVERSITY</b> LA TRINIDAD, BENGUET</p>	<p>OWNER</p>	<p><b>JOHN JAMES F. MALAMUG</b> VP ADMINISTRATION AND FINANCE</p>	<p><b>DIR. DANILO B. BOSE</b> SIC - PRESIDENT</p>	<p>END - USER</p>	<p>SHEET CONTENT</p>	SHEET NO.
												<p>AS SHOWN</p>	<p><b>A-2</b></p>
<p>REVISION DATE</p>	<p>REVISION NO.:</p>	<p><b>9</b></p>											

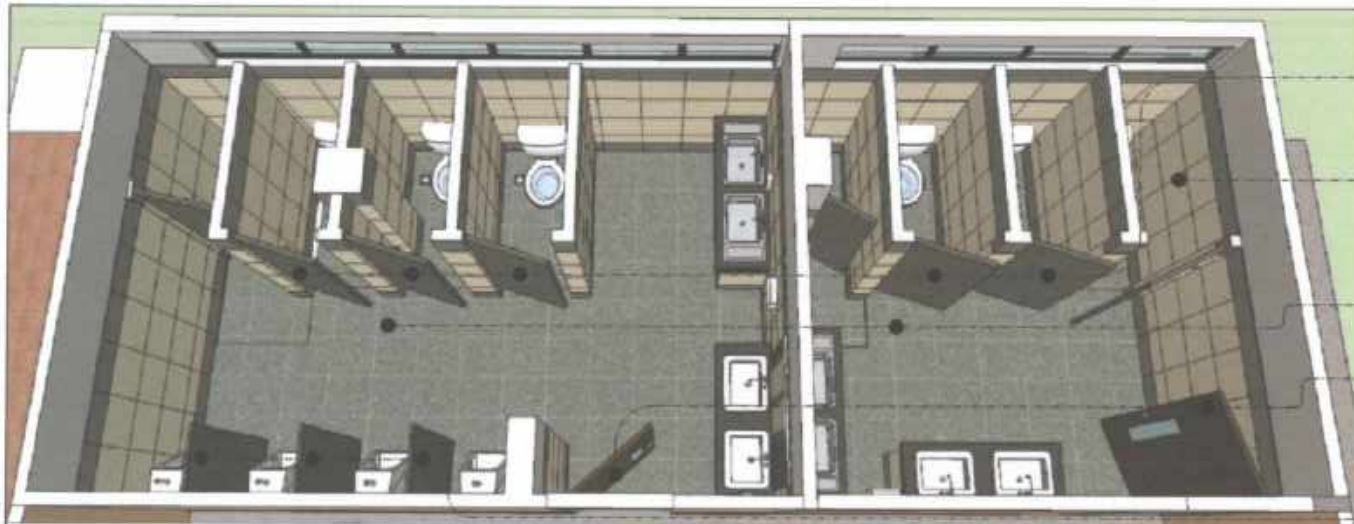

- Pre-fabricated hollow core/flush cubicle door
- 40mm x 40mm Porcelain glazed wall tiles
- 40mm x 40mm Porcelain Non-slip Textured floor tiles
- Pre-fabricated hollow core/flush door with peephole
- Pre-fabricated hollow core/flush cubicle door
- Fiber Cement Board Urinal Partition
- 40mm x 40mm Porcelain Glazed Wall tiles



**PERSPECTIVES (Male CR)**

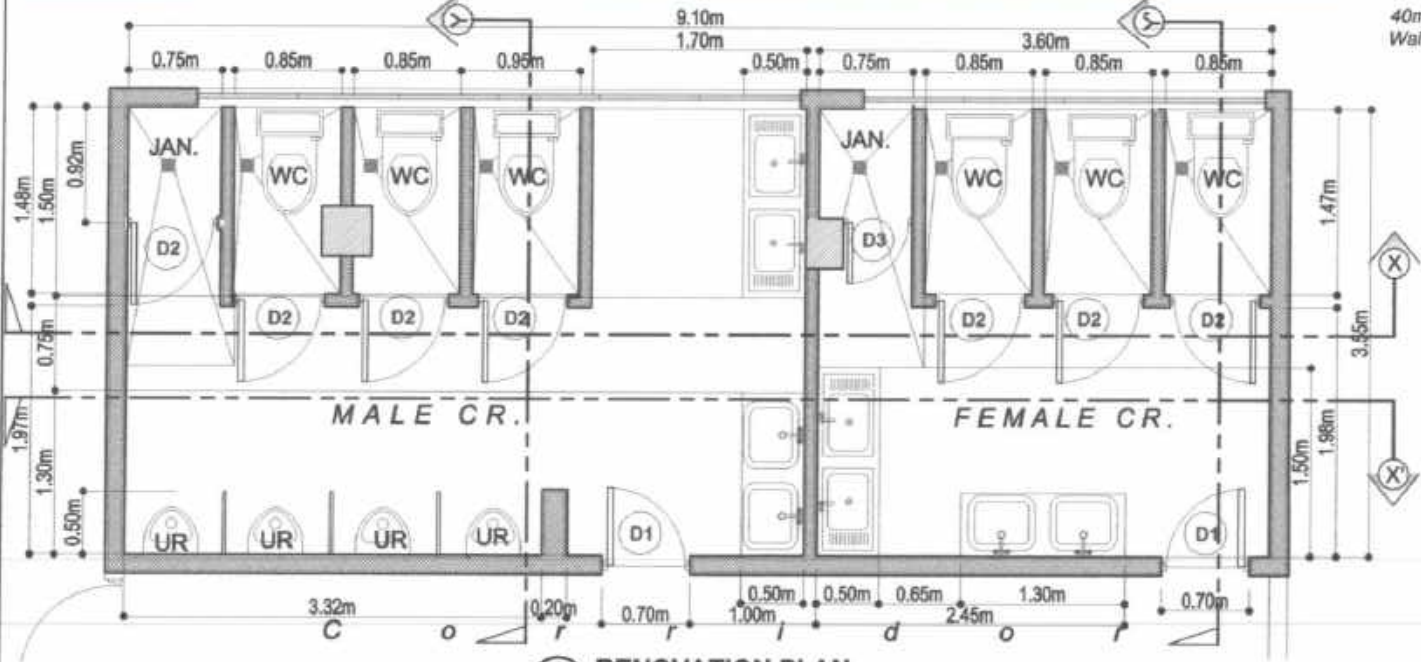


- 6mm thick Marine Plywood, Ceiling Board, Painted finish
- Granite Slab
- Pre-fabricated hollow core/flush cubicle door




**PERSPECTIVES (Female CR)**

**1 RENOVATION PLAN**  
SCALE 1:60MTS

<p><b>HAZELINE N. TIANGAY</b> UNIVERSITY ARCHITECT</p>	<p>PRC LIC. No. 028840 PTR No.</p>	<p>VALIDITY: ISSUED:</p>	<p>PRC LIC. No. PTR No.</p>	<p>VALIDITY: ISSUED:</p>	<p>DATE MADE: OCT. 2018 DATE: JULY 2020</p>	<p><b>REPAIR OF OLD ADMIN COMFORT ROOM</b> BSUJAM 5 BSU COMPOUND LA TRINIDAD, BENGUET</p>	<p><b>BENGUET STATE UNIVERSITY</b> LA TRINIDAD, BENGUET</p>	<p><b>JOHN JAMES F. MALAMUG</b> VP ADMINISTRATION AND FINANCE</p>	<p><b>DIR. DANLO B. BOSE</b> OIC - PRESIDENT</p>	<p>END-USER</p>	<p>SHEET CONTENT</p>	<p>SHEET NO.</p>
											<p>AS SHOWN</p>	<p>REVISION DATE:</p>
											<p>REVISION NO.:</p>	<p>9</p>

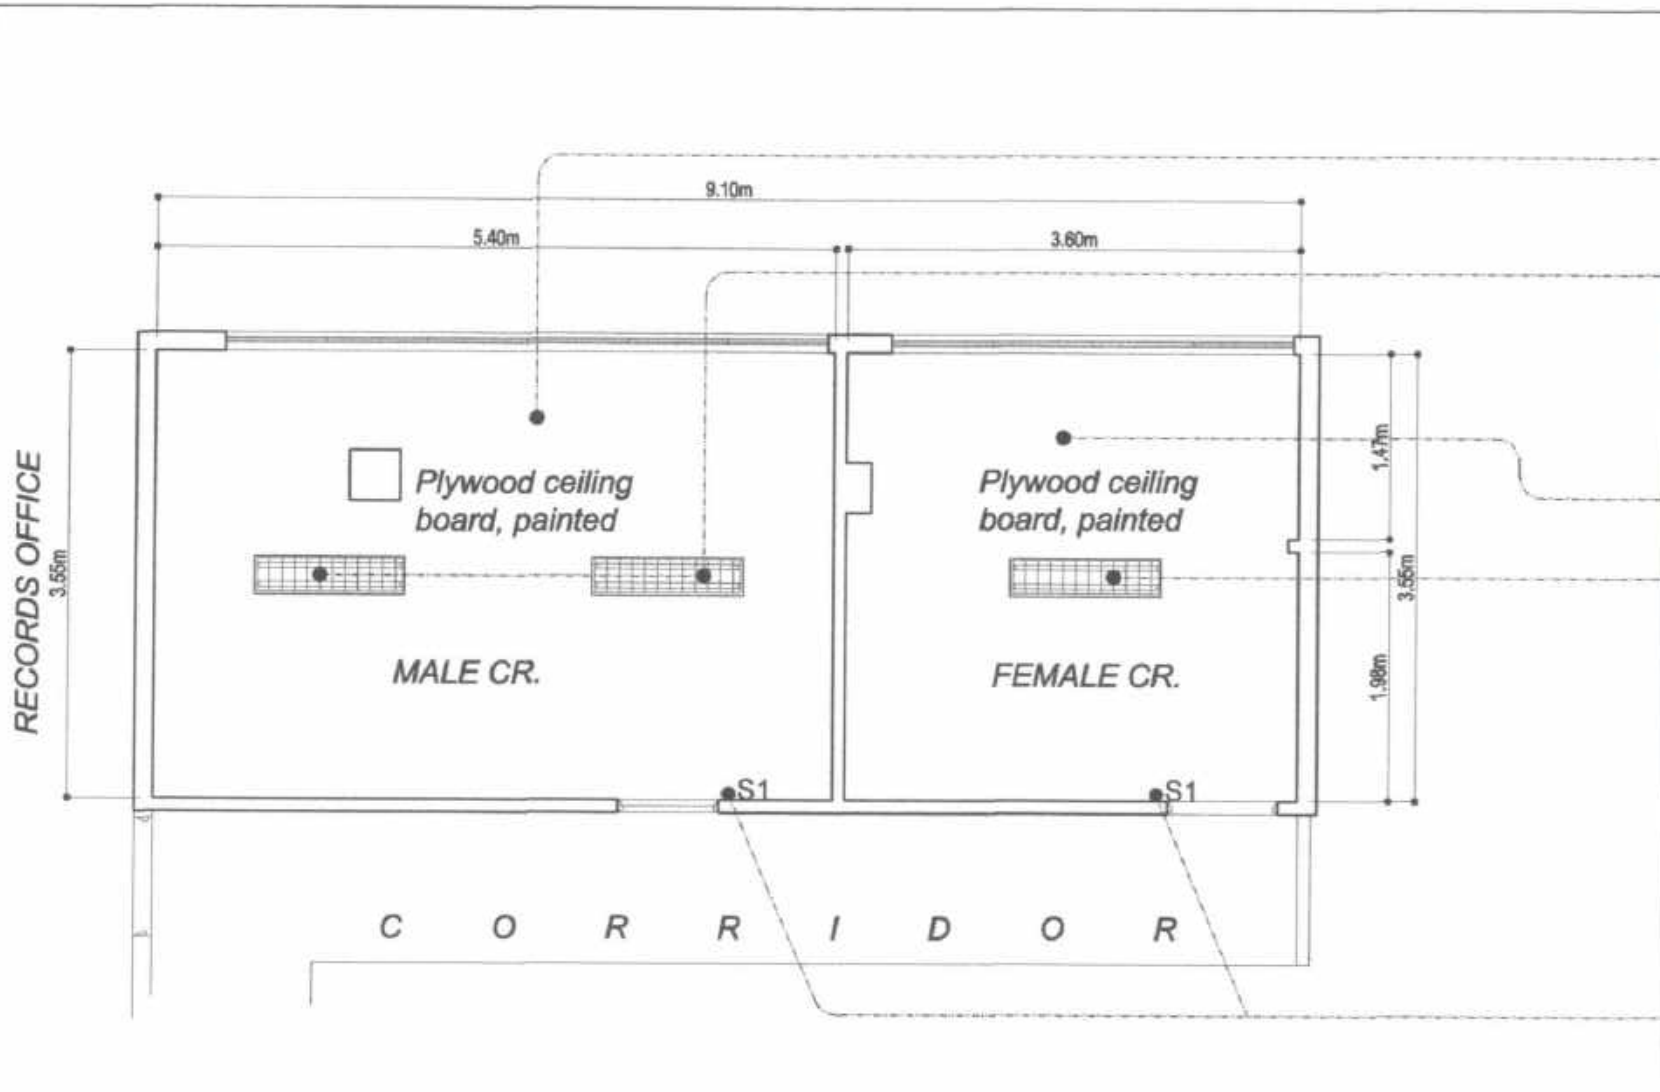

SITE PHOTOS

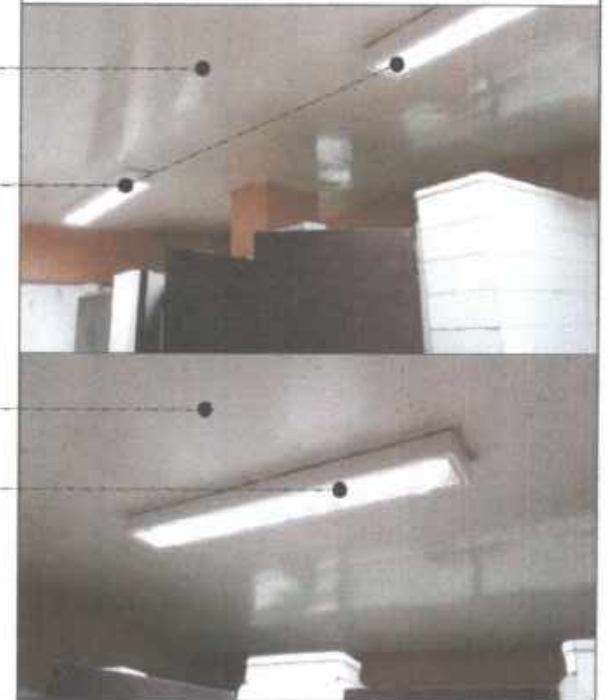


Existing plywood ceiling board to be removed and replaced with standard 6mm marine plywood, painted finished  
Existing lighting fixtures to be retained



Existing lighting fixture switch to be removed and replaced with two-gang switch

1 REFLECTED CEILING PLAN (As-built)  
A/4 SCALE 1:60MTS

 <b>HAZELINE N. PANGAY</b> UNIVERSITY ARCHITECT	PRC LIC. No. 028540 VAILDITY: ISSUED	PRC LIC. No. PTR No.	VALDITY: ISSUED	CDD BY: MADA/ OCT 2019 ENCL. JULY 2020	REPAIR OF OLD ADMIN COMFORT ROOM BSU, KM 5 BSU COMPOUND LA TRINIDAD, BENGUET	 <b>BENGUET STATE UNIVERSITY</b> LA TRINIDAD, BENGUET	 <b>JOHN JAMES F. MALAMUG</b> VP ADMINISTRATION AND FINANCE	 <b>DIR. DAMLO B. BOSE</b> oic- PRESIDENT	END-USER	SHEET CONTENT AS SHOWN REVISION DATE:	SHEET NO. <b>A-4</b>
										REVISION NO.:	<b>9</b>

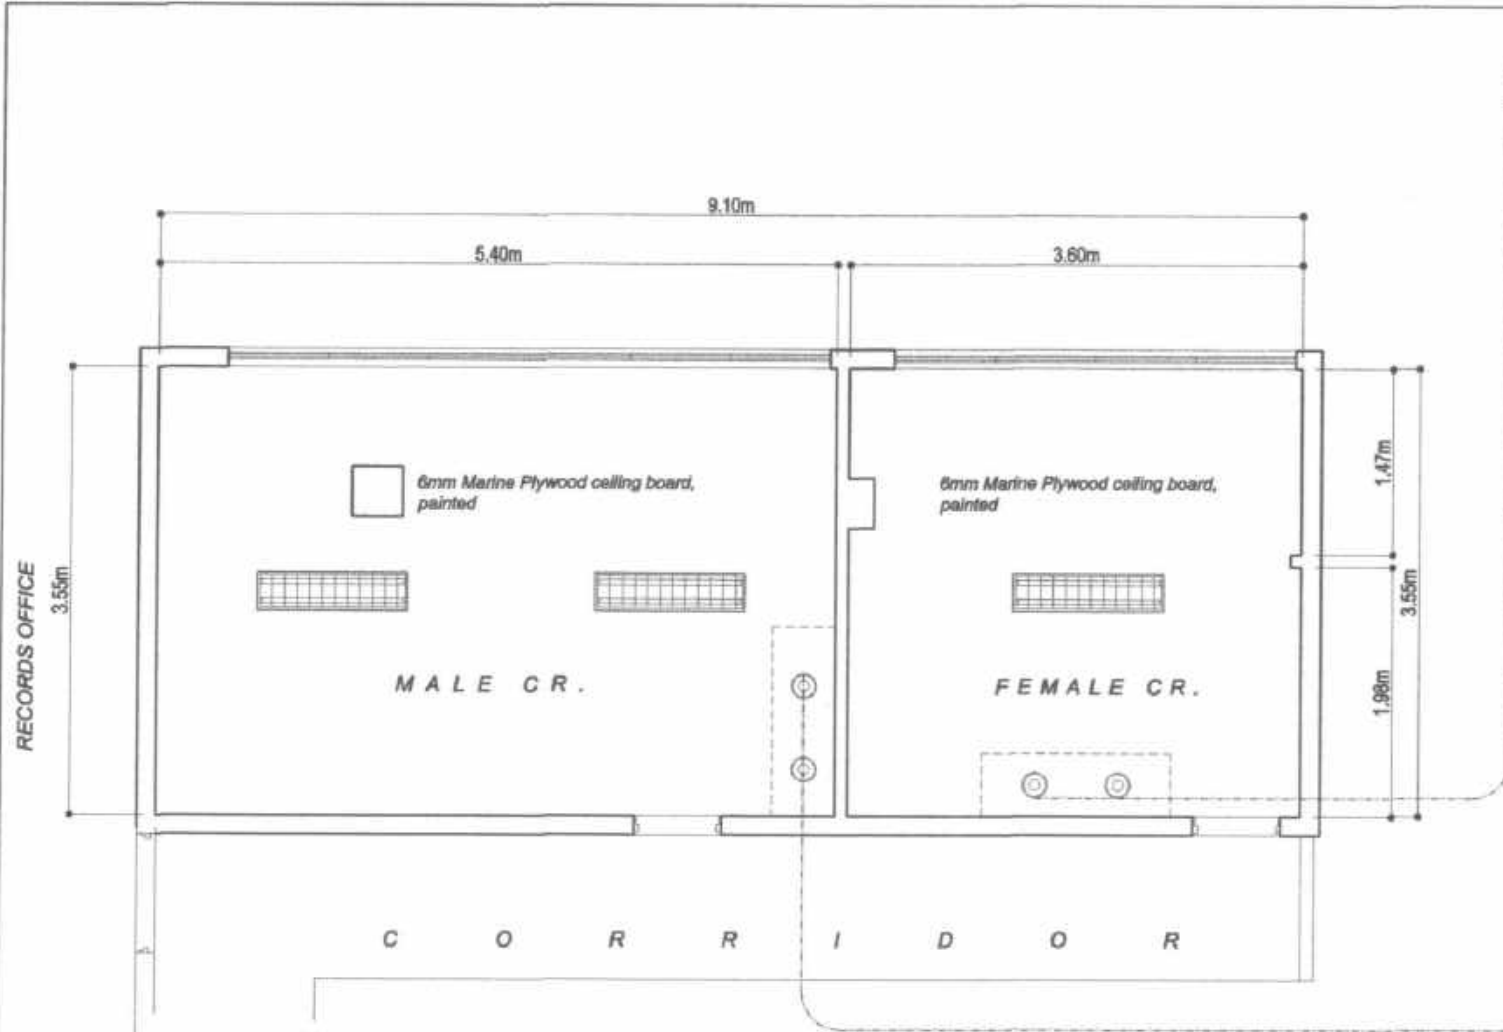

100mm Ø recessed pinlight (fixture and led bulb)

handryer, automatic, white

Liquid Soap Dispenser

6mm x 1.30m x 0.90 Vanity Mirror, Seamless, Bolt-on

Counter top Lavatory

Granite Slab



PERSPECTIVE WASH AREA (Female CR)

100mm Ø recessed pinlight (fixture and led bulb)

Masonry Wall, Paint Finish (off-white)

6mm x 1.30m x 0.90 Vanity Mirror, Seamless, Bolt-on

handryer, automatic, white

Liquid Soap Dispenser

Counter top Lavatory



40mmx40mm Porcelain Glazed Wall Tiles



PERSPECTIVE WASH AREA (Male CR)

1 REFLECTED CEILING PLAN (Renovation)  
SCALE 1:80MTS

<p>HAZELINE B. BANGAY UNIVERSITY ARCHITECT</p>	<p>PRC LIC. No. 028546 PTR No.</p>	<p>VALIDITY: ISSUED</p>	<p>REPAIR OF OLD ADMIN COMFORT ROOM BSU JMS BSU COMPOUND LA TRINIDAD, BENGUET</p>	<p>BENGUET STATE UNIVERSITY LA TRINIDAD, BENGUET</p>	<p>OWNER:</p>	<p>VP ADMINISTRATION AND FINANCE</p>	<p>DIR. DANKLO B. BOSE CIC-PRESIDENT</p>	<p>END-USER</p>	<p>SHEET CONTENT</p>	<p>SHEET NO.</p>
									<p>AS SHOWN</p>	<p>A-5</p>
									<p>REVISION DATE</p>	<p>9</p>
									<p>REVISION NO.</p>	

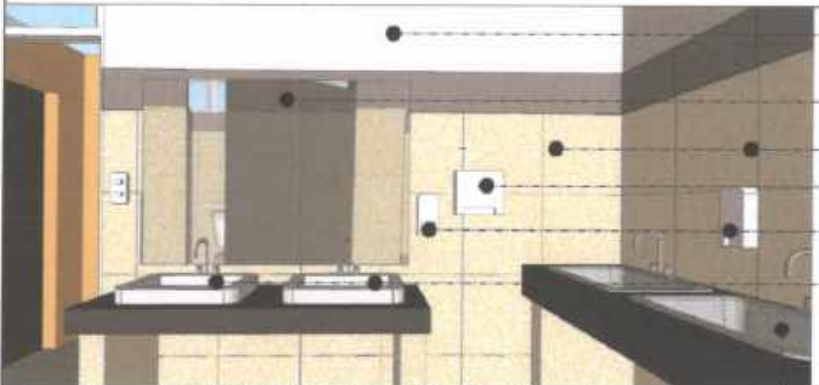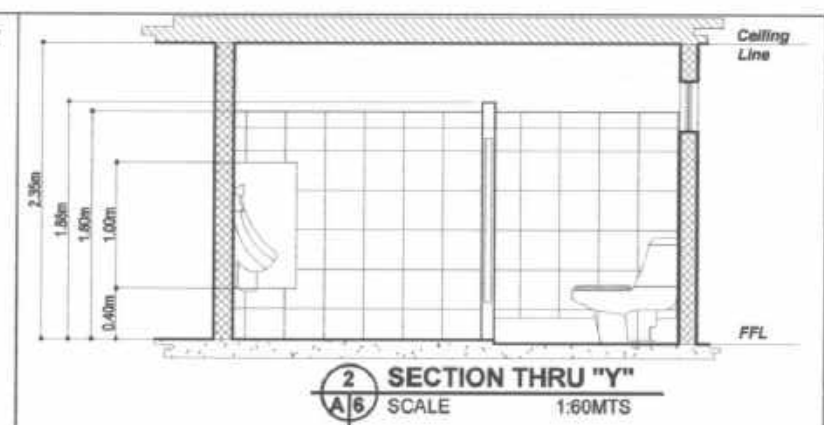

- Masonry Wall; Paint Finish (off-white)-----
- 6mm x 1.30m x 0.90 Vanity Mirror, Seamless, Bolt-on-----
- 40mmx40mm Porcelain Glazed Wall Tiles-----
- hundryer, automatic, white-----
- Liquid Soap Dispenser-----
- Fiber Cement Board Urinal Divider-----
- Counter top Lavatory-----
- Pre-fabricated hollow core/flush door with peephole-----
- Stainless Steel single tub kitchen sink, 18" w/ drain board-----









**WASH AREA (Female Comfort Room)**

**URINALS**




<p><b>HAZELINE R. BANGAY</b> UNIVERSITY ARCHITECT</p>	<p>PROJ. NO. 028848 ISSUED:</p>	<p>PROJ. NO. 028848 ISSUED:</p>	<p>VALIDITY: ISSUED:</p>	<p>REPAIR OF OLD ADMIN COMFORT ROOM BSU JMS BSU COMPOUND LA TRINIDAD, BENGUET</p>	<p><b>BENGUET STATE UNIVERSITY</b> LA TRINIDAD, BENGUET</p>	<p><b>JOHN JAMES F. MALAMUG</b> VP ADMINISTRATION AND FINANCE</p>	<p><b>DIR. DANILLO B. BOSE</b> SVP-PRESIDENT</p>	<p>END-USER</p>	<p>SHEET CONTENT</p>	SHEET NO.
									<p>AS SHOWN</p>	<p>A-6</p>
									<p>REVISION NO.:</p>	<p>9</p>

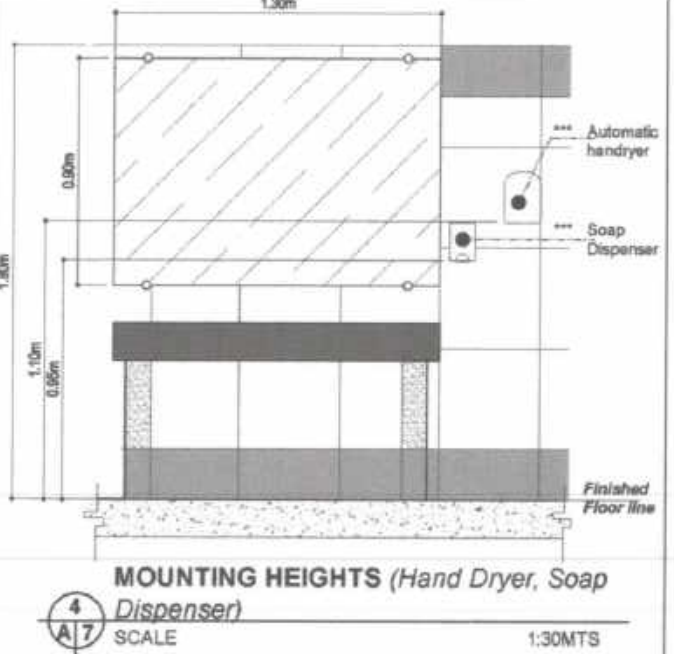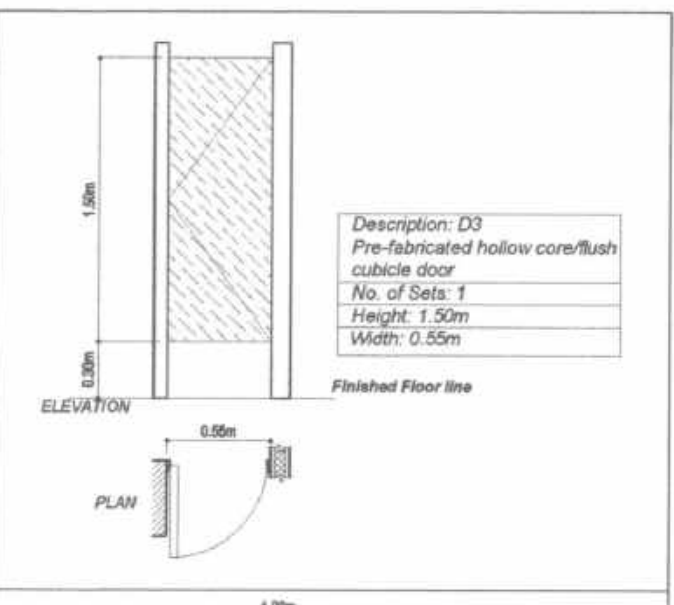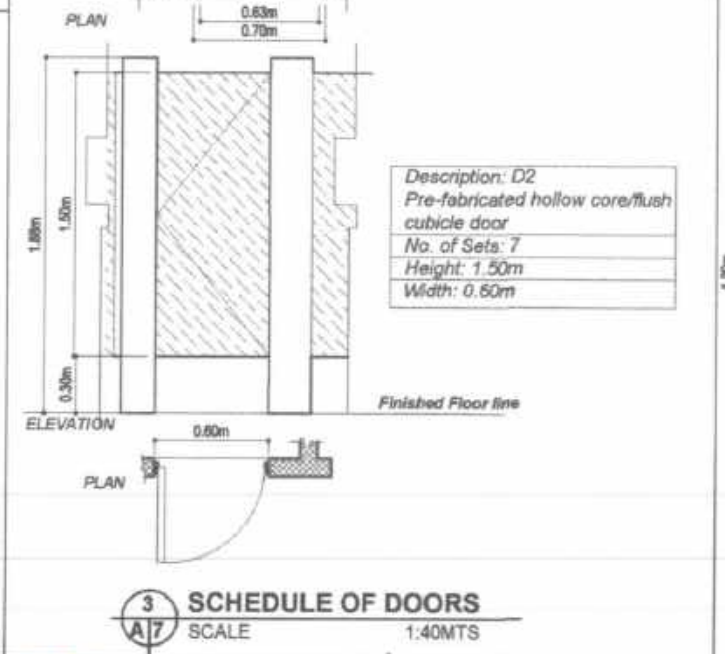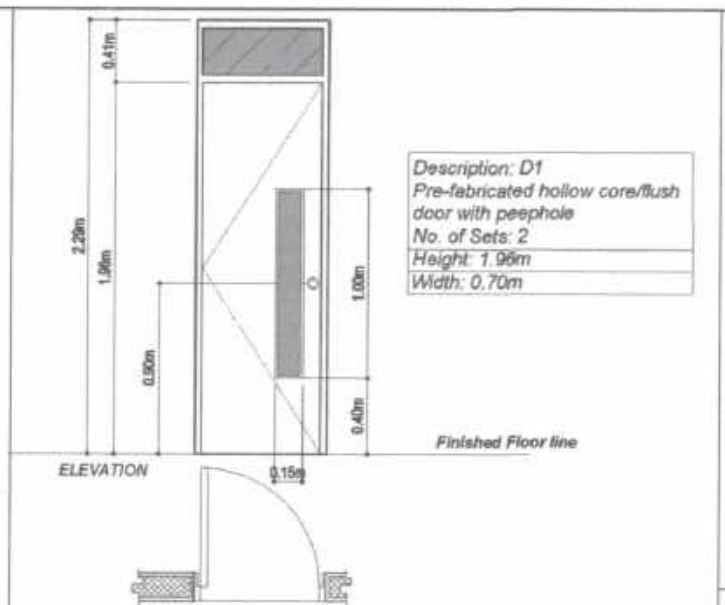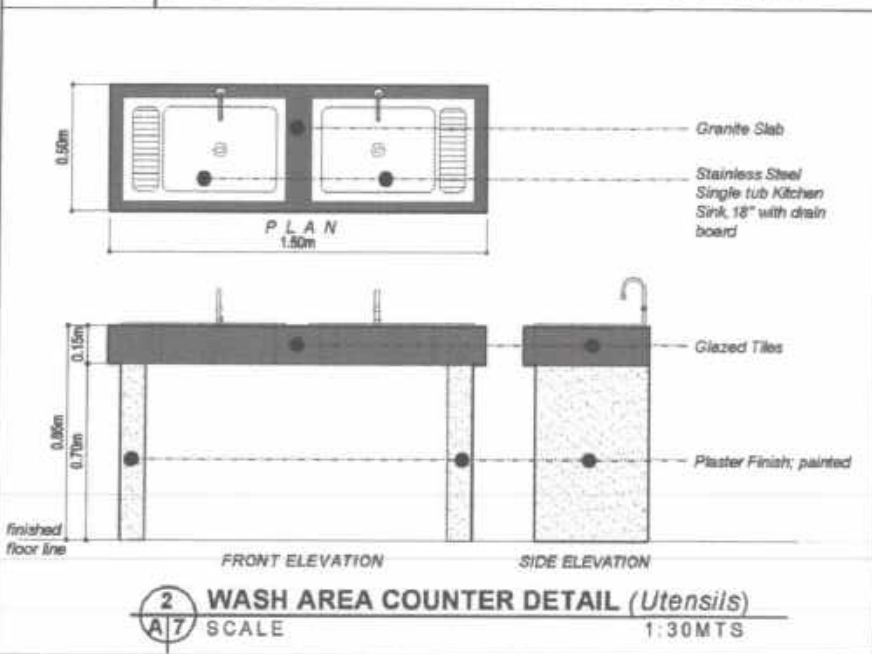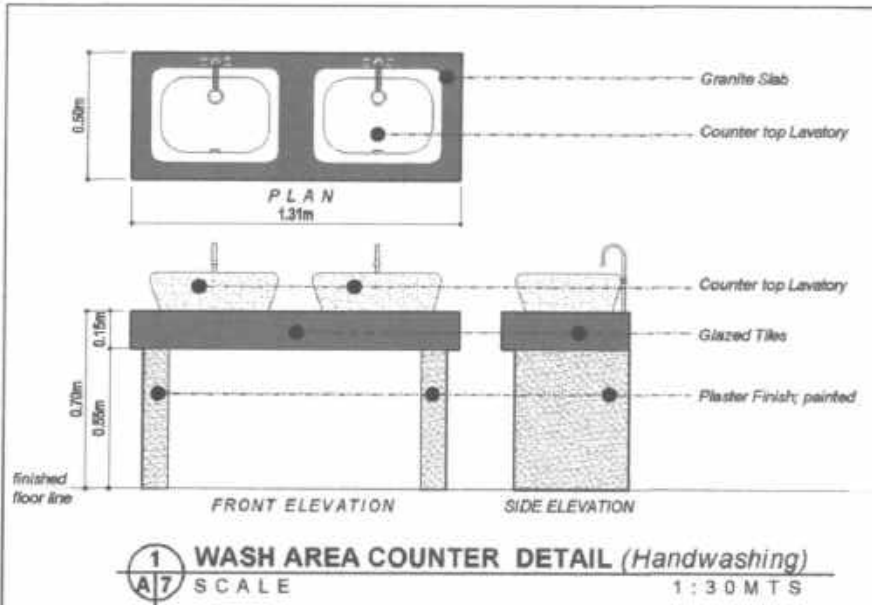

 <b>HAZELINE N. MANGAY</b> UNIVERSITY ARCHITECT	PRC LIC. No. 038549 PTR No.	VALIDITY: ISSUED	PRC LIC. No. PTR No.	VALIDITY: ISSUED	CAD BY: MANDY, OCT 2019 ENG. JULY 2020	 <b>BENGUET STATE UNIVERSITY</b> LA TRINIDAD, BENGUET	<b>ORDER</b>	 <b>JOHN JAMES F. MALAMUG</b> VP ADMINISTRATION AND FINANCE	 <b>DIR. DANILLO B. BOSE</b> OIC - PRESIDENT	END-USER	SHEET CONTENT: AS SHOWN	SHEET NO. A-7
											REVISION DATE:	REVISION NO.: 9

AUG 19 2020  
 By:

RECORDS OFFICE


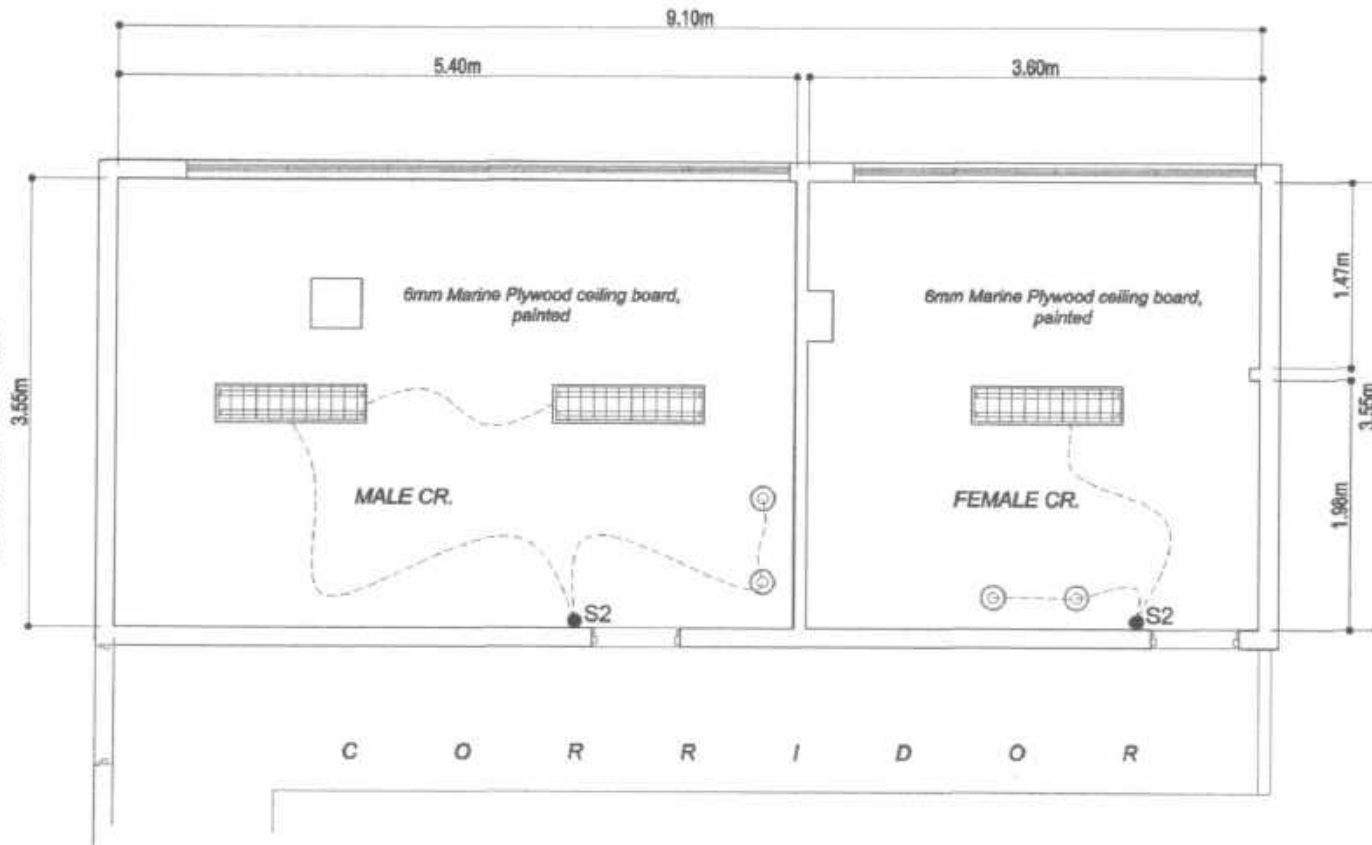


\*\*\*Installation of 100mm dia. Recessed Pinlight  
 \*\*\*Replacement of existing lighting fixture switch

**1** ELECTRICAL LIGHTING LAYOUT  
 SCALE 1 : 60 MTS

**LEGEND**






- 2- T8 LED Lighting Fixture with surfaced housing and diffuser
- Two-gang switch element
- Switch Line
- 100mm dia Recessed Pinlight

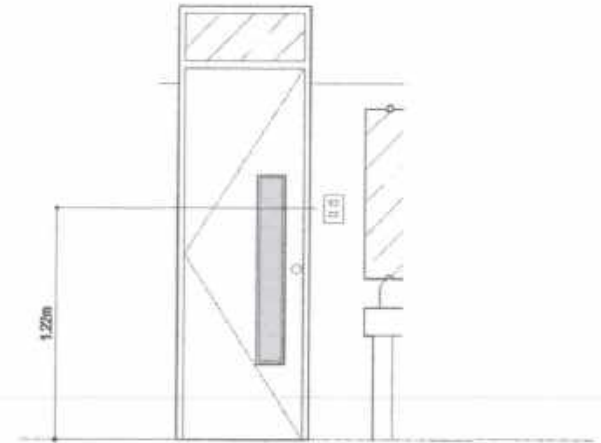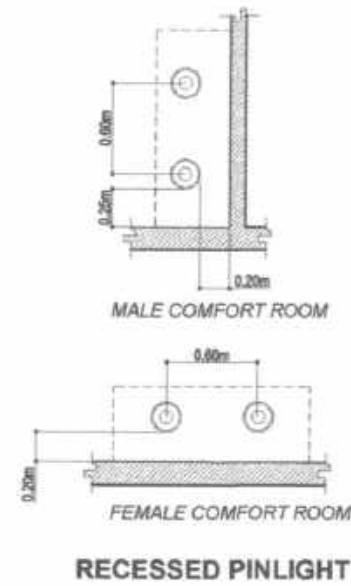

**2** MOUNTING HEIGHT  
 SCALE 1:40MTS

 <b>HAZELINE N. MANGAY</b> UNIVERSITY ARCHITECT	PRC LIC. No. 028540 PTR No. ISSUED	VALIDITY: ISSUED	REPAIR OF OLD ADMIN COMFORT ROOM BSU, KM 5 BSU COMPOUND LA TRINIDAD, BENGUET PROJECT / LOCATION	 <b>BENGUET STATE UNIVERSITY</b> LA TRINIDAD, BENGUET OFFICE	 <b>JOHN JAMES F. MALAMUG</b> VP ADMINISTRATOR AND FINANCE	 <b>DIR. DANILLO B. BOSE</b> OIC - PRESIDENT	END-USER	SHEET CONTENT	SHEET NO.
								AS SHOWN REVISION DATE: REVISION NO.:	E-1 9



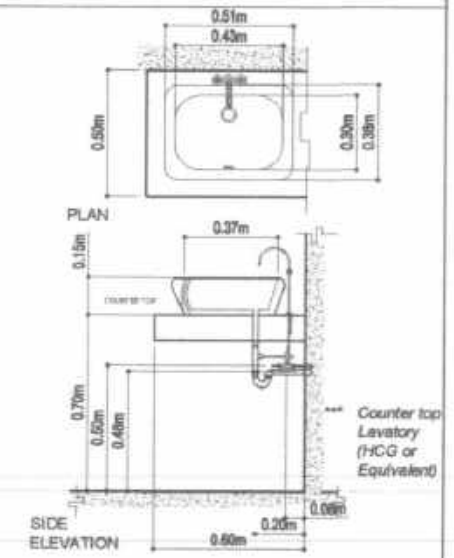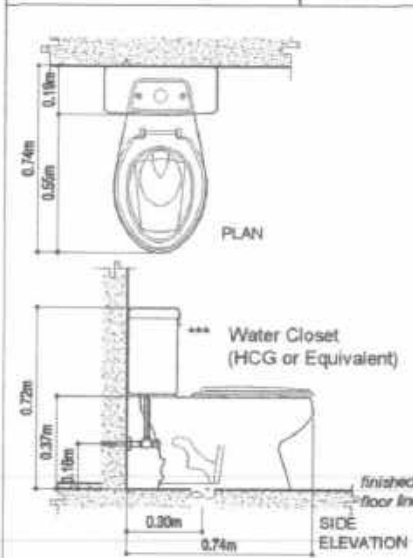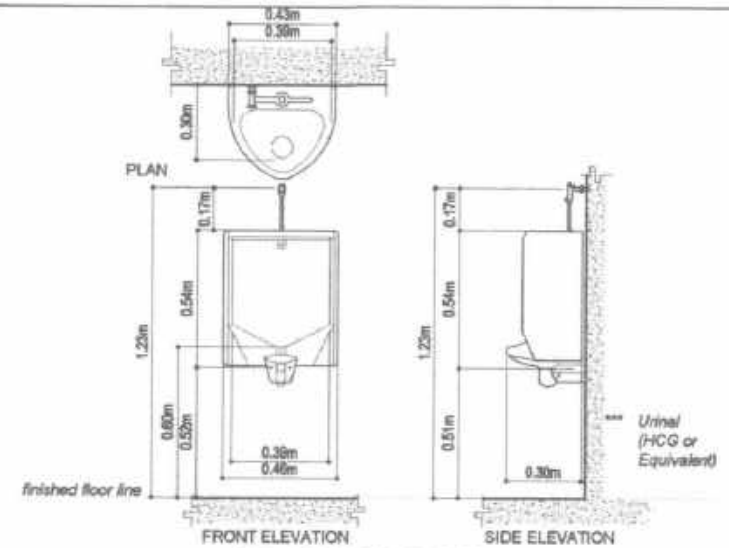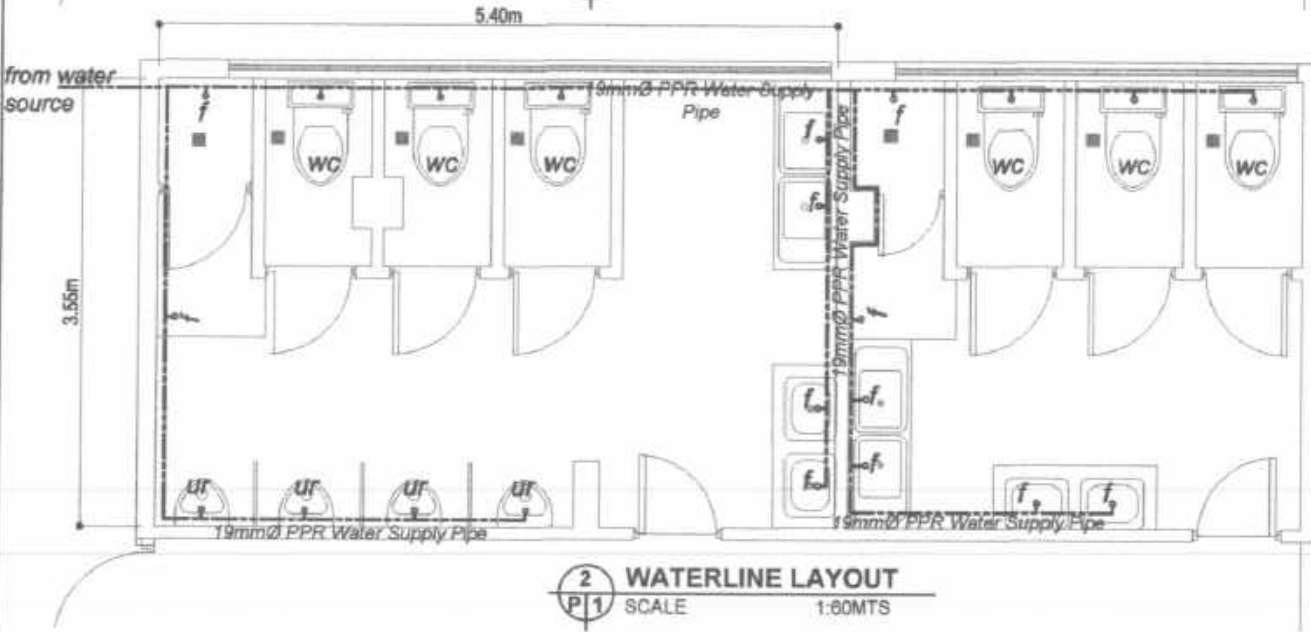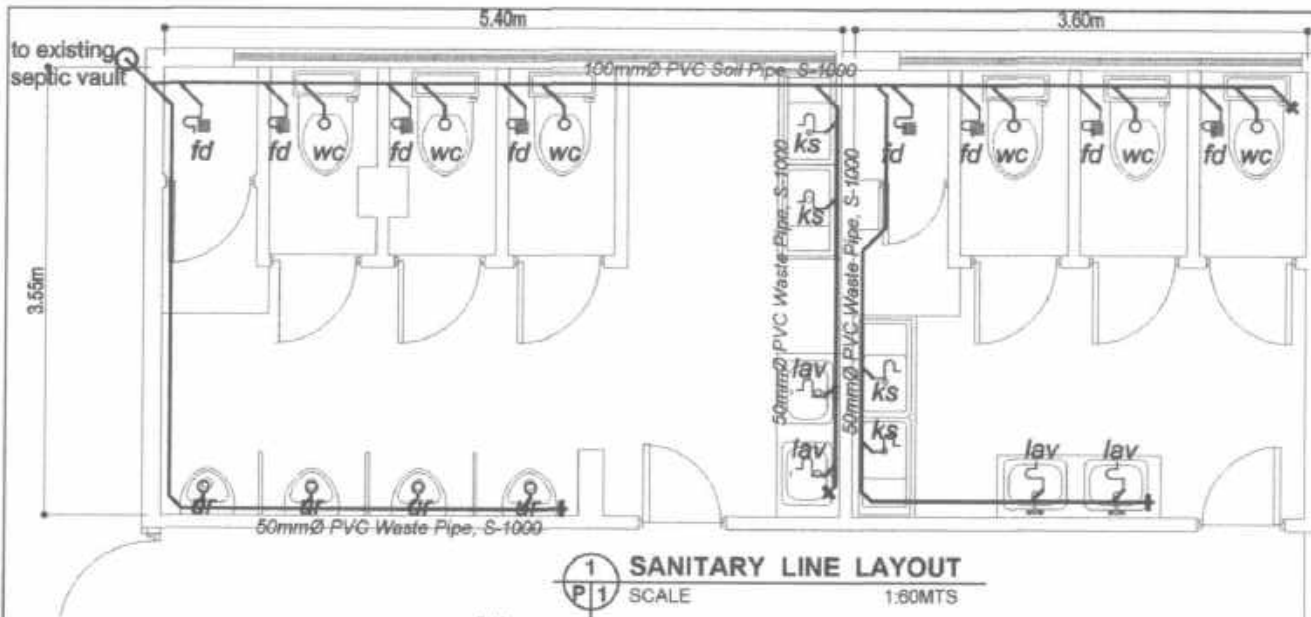

HAZELINE N. BANGAY  
UNIVERSITY ARCHITECT

PRC LIC. No. 038540  
PTR No. 038540

VALIDITY:  
ISSUED

PRC LIC. No.  
PTR No.

VALIDITY:  
ISSUED

MADE BY: MAZON, OCT 2019  
EMUL, JULY 2008

REPAIR OF OLD ADMIN COMFORT ROOM

BSU, RM 5 BSU COMPOUND LA TRINIDAD, BENGUET

PROJECT / LOCATION



BENGUET STATE UNIVERSITY  
LA TRINIDAD, BENGUET

CONTRATOR

JOHN JAMES F. MALAMUG  
VP ADMINISTRATION AND FINANCE

DIR. DAN LO B. BOSE  
CIC-PRESIDENT

END-USER

SHEET CONTENT: AS SHOWN  
REVISION DATE:

SHEET NO. P-1

Procurement Office  
BENGUET STATE UNIVERSITY

By: AUG 13 2020